

Management Division  
Department of Health Service  
Ministry of Health & Population



Health Building Infrastructure  
Standard Design Drawings


Job Name:-  
PRIMARY HOSPITAL CLASS B  
TYPE 2  
RCC Frame Structure  
Two Storied

SCALE:-

DATE :

Drawing Title  
GROUND FLOOR  
PLAN

Sheet no:  
AR/ 01  
01/08

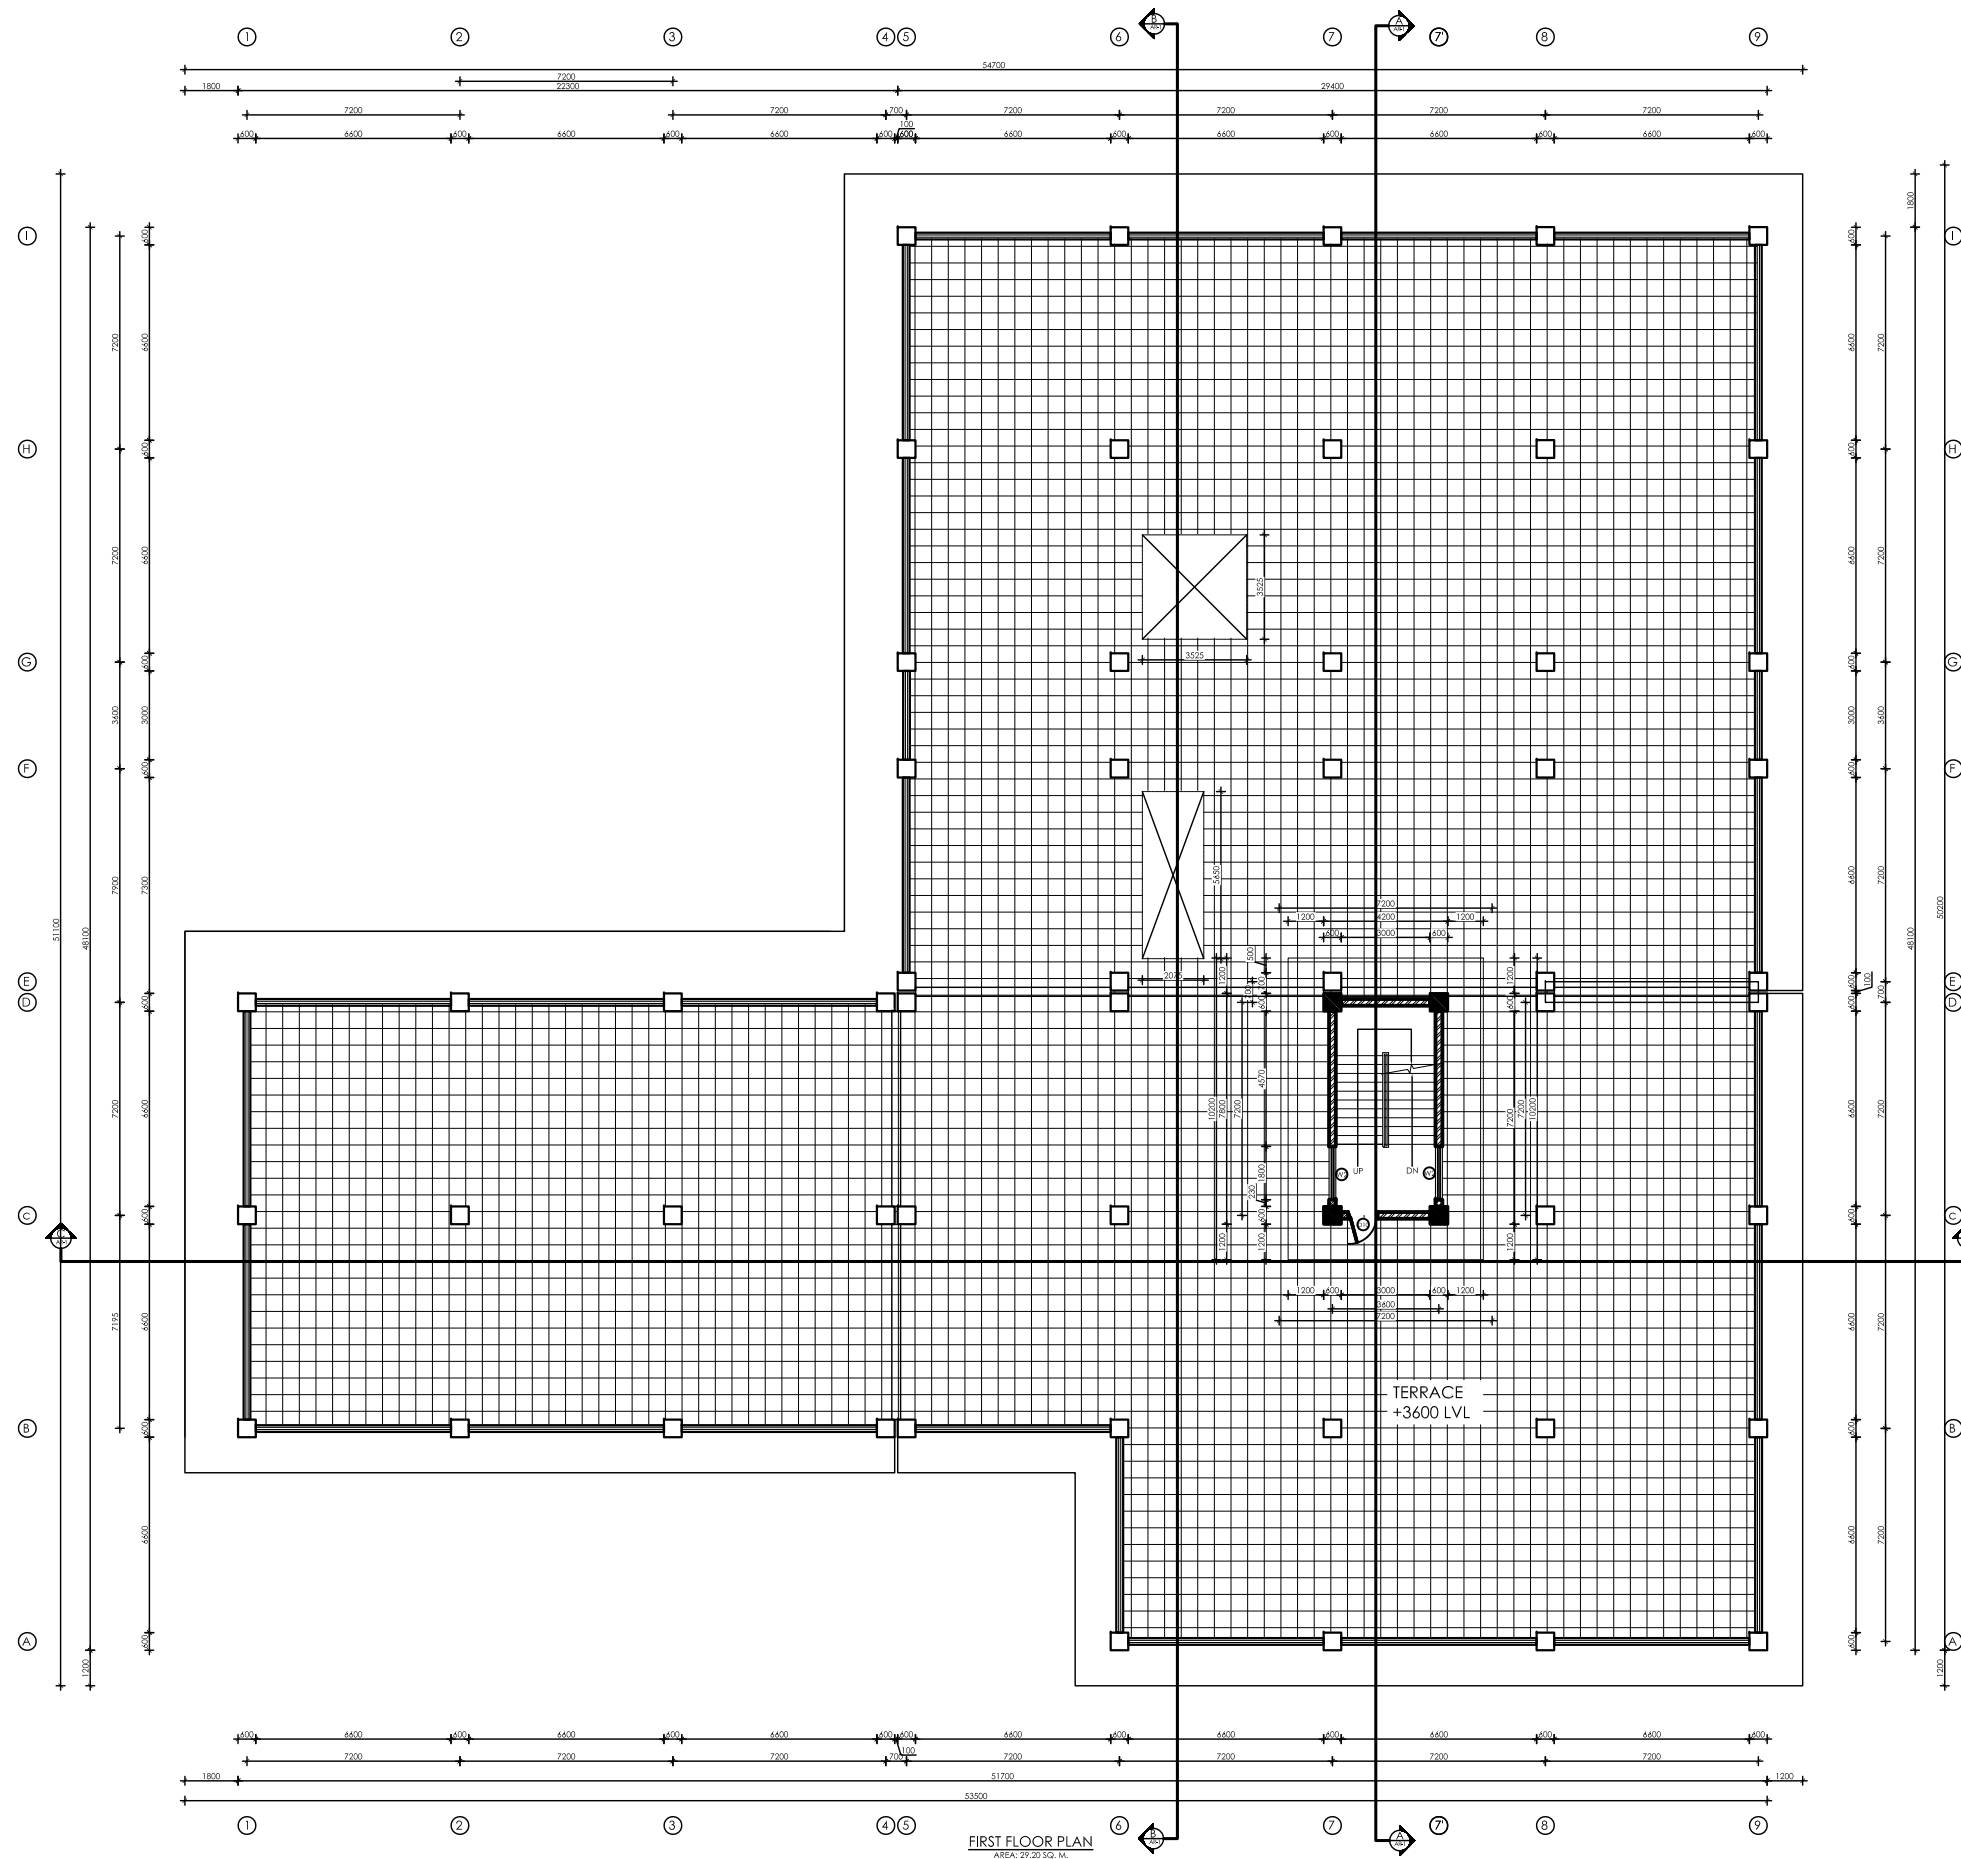

Management Division  
Department of Health Service  
Ministry of Health & Population



Health Building Infrastructure  
Standard Design Drawings

Job Name:-  
PRIMARY HOSPITAL CLASS B  
TYPE 2  
RCC Frame Structure  
Two Storied

SCALE:-

DATE :

Drawing Title

FIRST FLOOR PLAN

Sheet no:

AR/02  
02/08